


Saved: 02-12-2016 6:52:53 AM by BMC
 Plot Scale: 1" = 30' - 12-2016 10:10:13 AM by BRIAN COOMES
 U:\Pittsburg\2014\14E14\000\Main Drawings\Plan Set\14E14-000_C-100_Ext Cond-Surv Cont

CONSTRUCTION DOCUMENTS

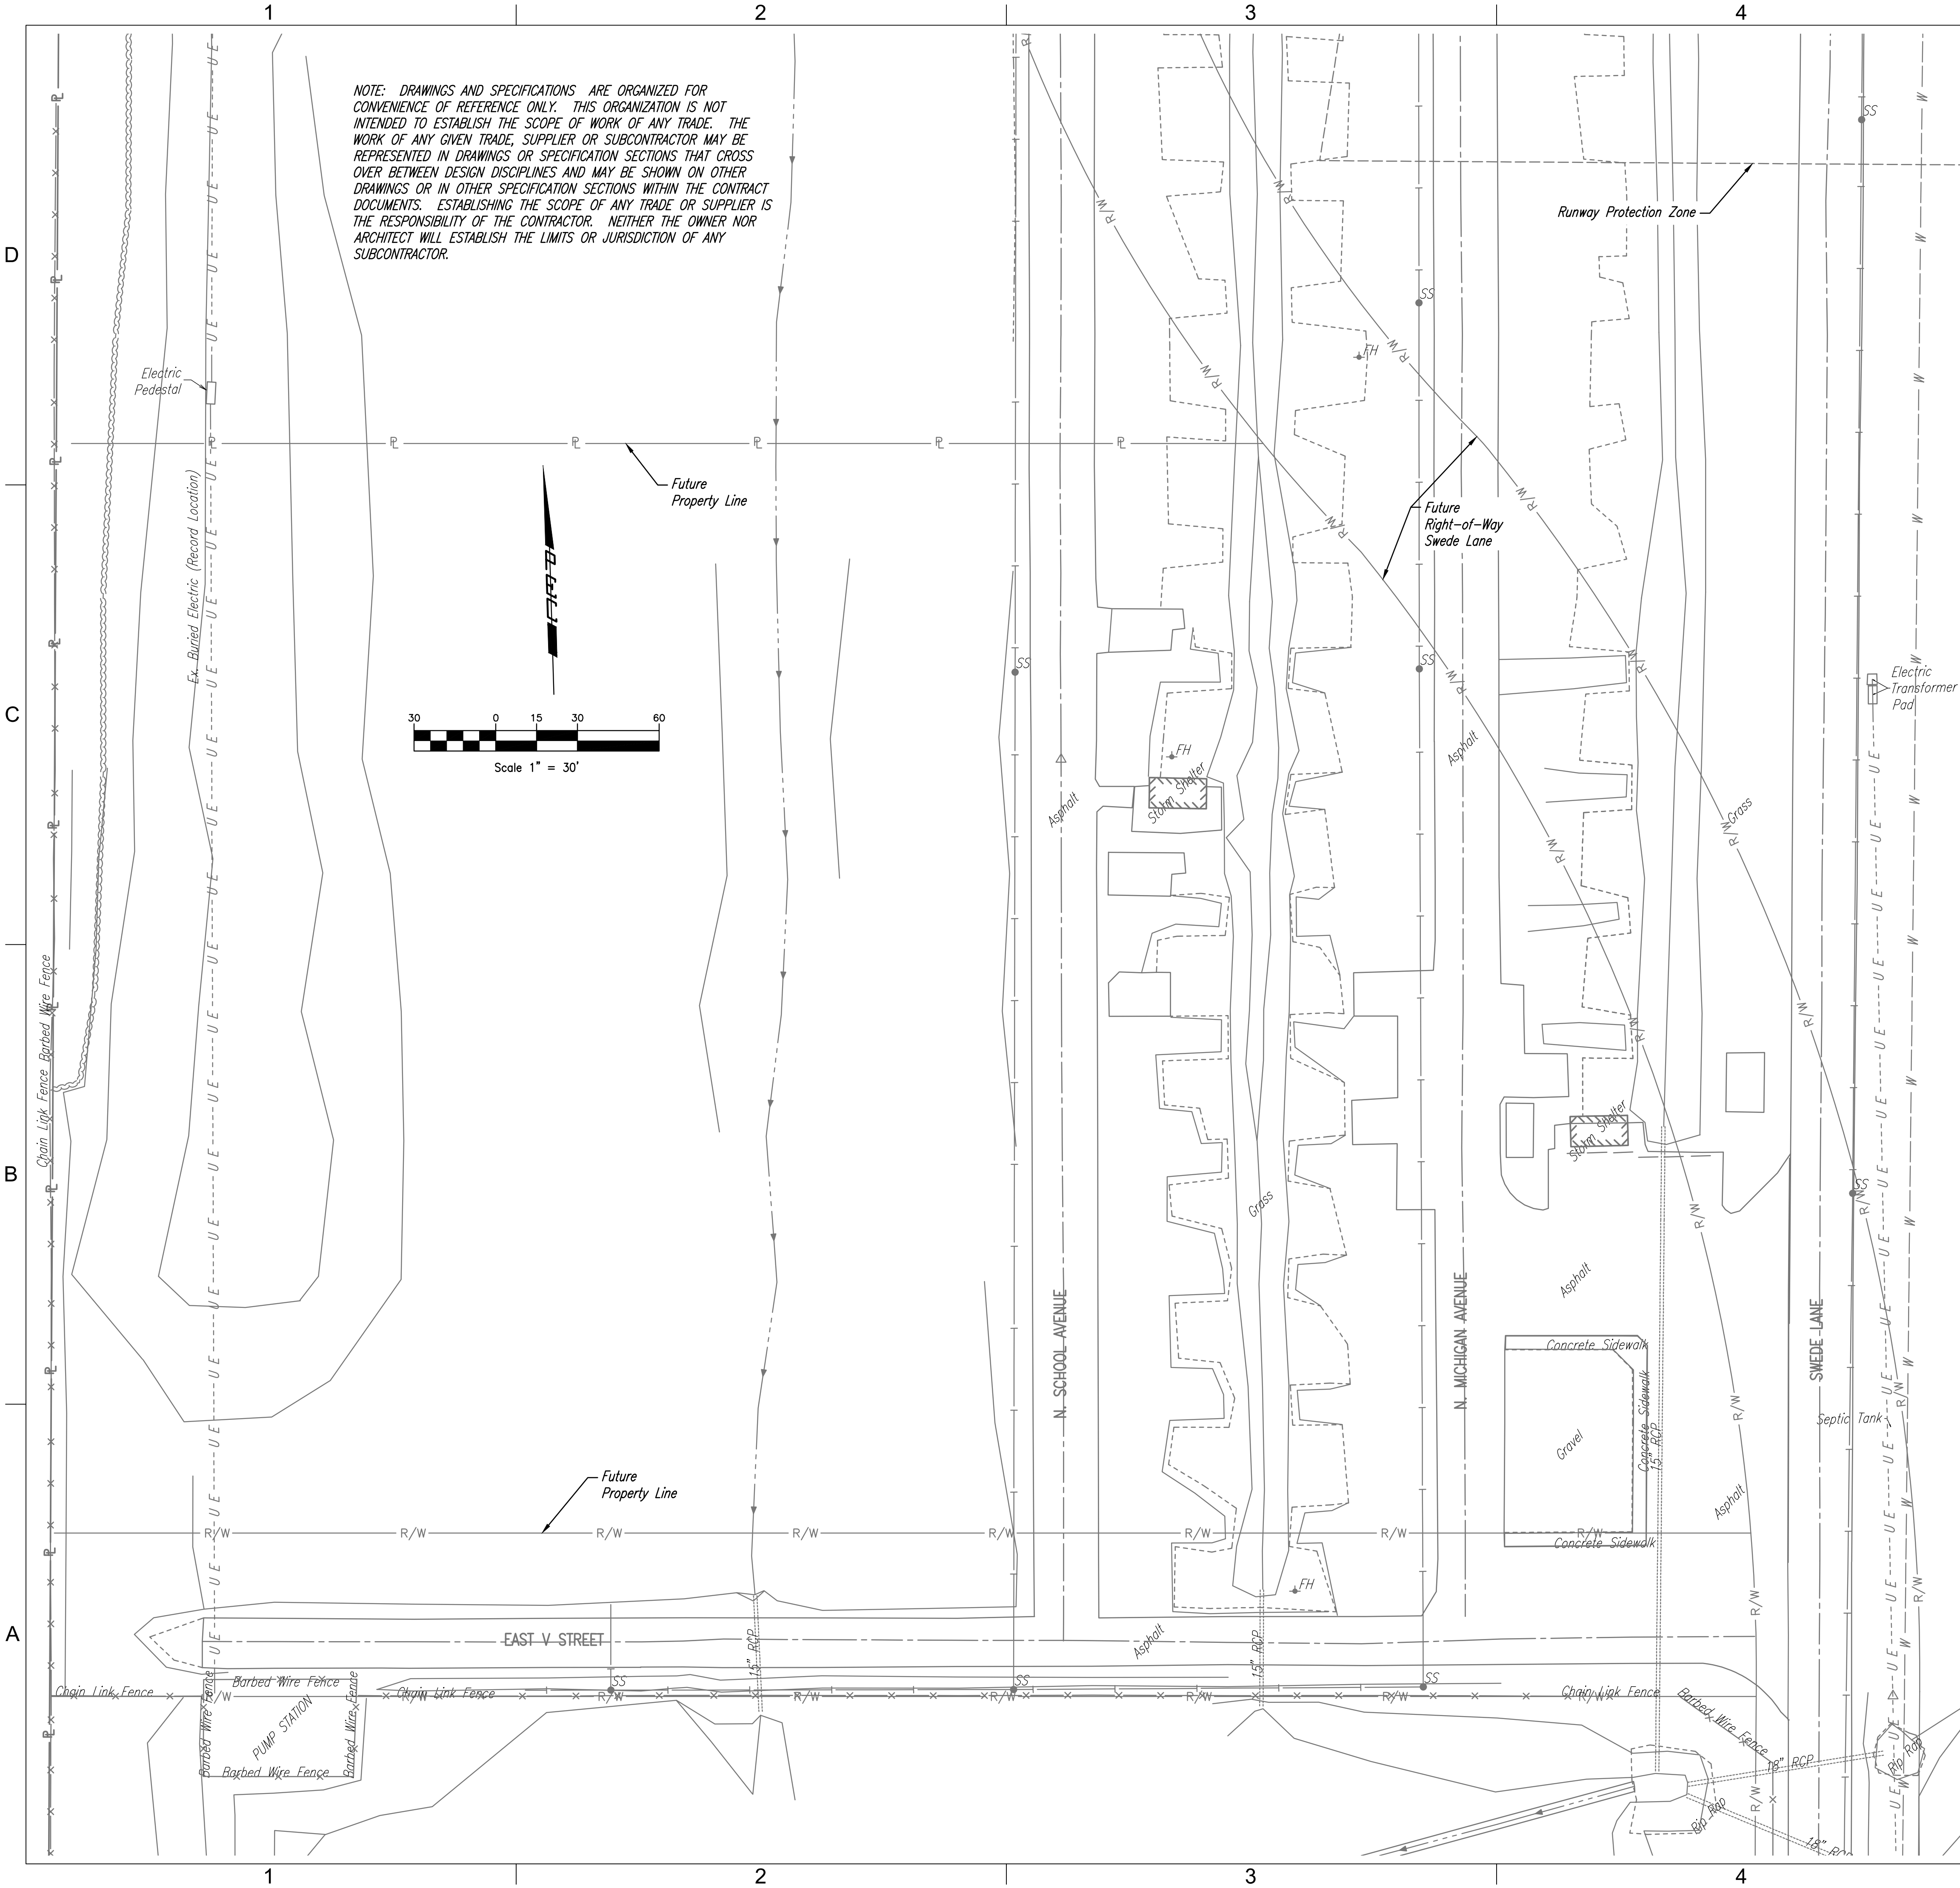

NOTE: DRAWINGS AND SPECIFICATIONS ARE ORGANIZED FOR CONVENIENCE OF REFERENCE ONLY. THIS ORGANIZATION IS NOT INTENDED TO ESTABLISH THE SCOPE OF WORK OF ANY TRADE. THE WORK OF ANY GIVEN TRADE, SUPPLIER OR SUBCONTRACTOR MAY BE REPRESENTED IN DRAWINGS OR SPECIFICATION SECTIONS THAT CROSS OVER BETWEEN DESIGN DISCIPLINES AND MAY BE SHOWN ON OTHER DRAWINGS OR IN OTHER SPECIFICATION SECTIONS WITHIN THE CONTRACT DOCUMENTS. ESTABLISHING THE SCOPE OF ANY TRADE OR SUPPLIER IS THE RESPONSIBILITY OF THE CONTRACTOR. NEITHER THE OWNER NOR ARCHITECT WILL ESTABLISH THE LIMITS OR JURISDICTION OF ANY SUBCONTRACTOR.

TOPOGRAPHIC SURVEY NOTES:

TOPOGRAPHIC SURVEY & APPROXIMATE PROPERTY BOUNDARIES PROVIDED BY OTHERS:

TRI-STATE ENGINEERING, INC.
702 S. MAIN
JOPLIN, MO 64801
(417) 781-0643

HORIZONTAL CONTROL:

HORIZONTAL DATUM - COORDINATES SHOWN FOR THIS PROJECT ARE GRID COORDINATES BASED ON THE MISSOURI STATE PLANE COORDINATE SYSTEM OF 1983 (WEST ZONE).

SITE CONTROL:
NGS FBN CONTROL STATION JS 009

FOR MORE DETAILED INFORMATION REGARDING HORIZONTAL CONTROL, CONTACT TRI-STATE ENGINEERING, INC.

VERTICAL CONTROL:

VERTICAL DATUM - ELEVATIONS SHOWN FOR THIS PROJECT ARE BASED ON THE NORTH AMERICAN DATUM OF 1988 (NAVD88).

TBM "A" = 978.98
FIRE HYDRANT BOLT BETWEEN MUE & LLER 18 FEET EAST OF CENTER LINE OF SWEDE LANE AT "E" STREET. FIRST FIRE HYDRANT SOUTH OF DETENTION POND

TBM "B" = 977.29
CHISELED SQUARE ON TOP OF THE SOUTHWEST CORNER OF THE WEIR STRUCTURE AT THE WEST END OF DETENTION POND ON THE EAST SIDE OF SWEDE LANE

INDEX OF DRAWINGS

CIVIL DISCIPLINE

- C100 Existing Conditions/Survey Control
- C101 Demolition Plan/General Notes
- C102 Site Plan
- C103 Site Plan Details
- C104 Add Alternate Plan
- C105 Grading Plan
- C106 Grading Plan Details
- C107 Coordinate Plan
- C108 Coordinate Tables
- C109 Coordinate Plan Details/Tables
- C110 Paving Details 1 of 3
- C111 Paving Details 2 of 3
- C112 Paving Details 3 of 3
- C113 Water Line/Sanitary Sewer Plan
- C114 Water Line Profiles
- C115 Water Line/Sanitary Sewer Details
- C116 Bedding & Backfill Details
- C117 Franchised Utility Plan
- C118 Storm Sewer Plan 1 of 2
- C119 Storm Sewer Plan 2 of 2
- C120 Storm Sewer Profile
- C121 Extended Dry Detention Basin Plan
- C122 Extended Dry Detention Basin Details
- C123 Miscellaneous Storm Sewer Details
- C124 Type 22 Curb Inlet Details
- C125 Type 22 Precast Inlet Details
- C126 Reinforced Concrete Manhole Details
- C127 Drainage Area Map
- C128 Boring Logs/Earthwork Requirements - 1 of 2
- C129 Boring Logs/Earthwork Requirements - 2 of 2
- C130 Lighting Layout Plan/Coordinates Table
- C131 Erosion Control Plan

GLMV Architecture
9229 Ward Parkway, Ste. 210
Kansas City, MO 64114
Tel: (816) 444-4200
www.glmv.com
PEC
PROFESSIONAL ENGINEERING CONSULTANTS, P.A.
104 SOUTH PINE PITTSBURG, KS 66762
620-235-0195 www.pec1.com
STATE CERT. OF AUTHORITY NO. 000465
PEC PROJECT # 14E14-000



CONSTRUCTION DOCUMENTS

© 2016 GLMV Architecture, Inc.
All work herein is the exclusive property of GLMV Architecture, Inc. and is not to be copied or used in any way without the express written consent of GLMV Architecture, Inc. All drawings, specification, ideas, designs and arrangements appearing herein constitute the original and unpublished Work of GLMV Architecture, Inc.

JOPLIN PUBLIC SAFETY TRAINING FACILITY
5102 SWEDE LANE, JOPLIN, MO

CONSTRUCTION DOCUMENTS

EXISTING CONDITIONS/ SURVEY CONTROL

JOB NO.	13061.000	C100
DATE	02-12-2016	
DRAWN	BMC	
CHECKED	BDR	
DWG.	5 OF 141	